


EXHIBIT - 5.2

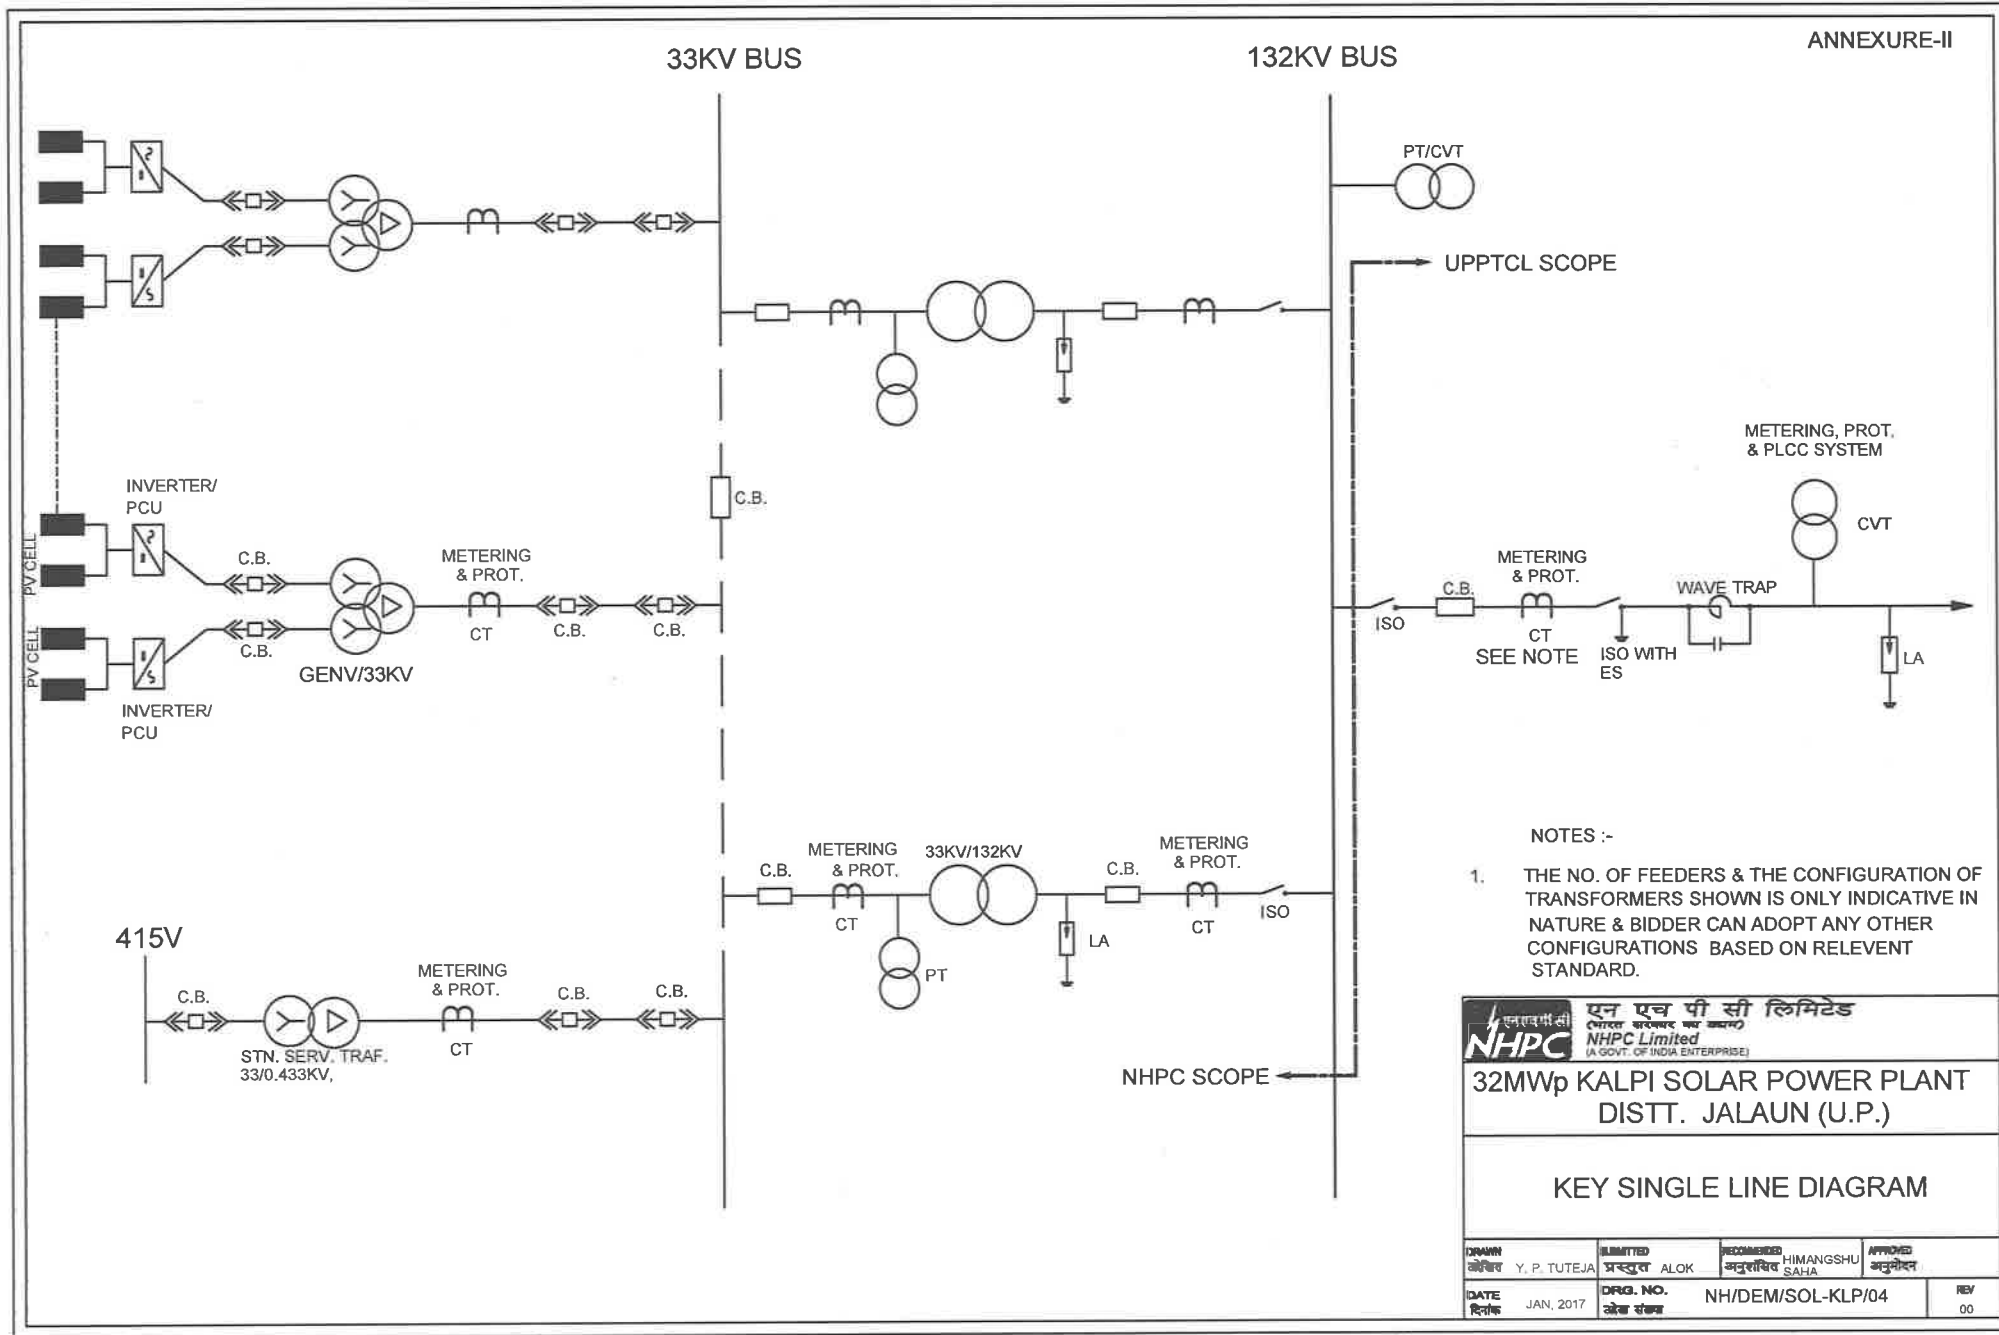

ANNEXURE-II

NOTES :-

1. THE NO. OF FEEDERS & THE CONFIGURATION OF TRANSFORMERS SHOWN IS ONLY INDICATIVE IN NATURE & BIDDER CAN ADOPT ANY OTHER CONFIGURATIONS BASED ON RELEVANT STANDARD.

		एन एच पी सी लिमिटेड <small>(एन एच पी सी लिमिटेड)</small> NHPC Limited <small>(A GOVT. OF INDIA ENTERPRISE)</small>	
32MWp KALPI SOLAR POWER PLANT DISTT. JALAUN (U.P.)			
KEY SINGLE LINE DIAGRAM			
DRAWN <small>आरेखित</small>	SUBMITTED <small>प्रस्तुत</small>	RECOMMENDED <small>अनुशंसित</small>	APPROVED <small>अनुमोदित</small>
<small>Y. P. TUTEJA</small>	<small>ALOK</small>	<small>HIMANGSHU SAHA</small>	<small>अनुमोदित</small>
DATE <small>दिनांक</small>	DRG. NO. <small>आरेख संख्या</small>	<small>NH/DEM/SOL-KLP/04</small>	REV <small>00</small>
<small>JAN, 2017</small>			

Handwritten signature